

webster  
dalton  
day  
rohrman


architects  
engineers

bangor, maine

1494

N.M.V.T.I.  
SHOP

PRESQUE ISLE  
MAINE

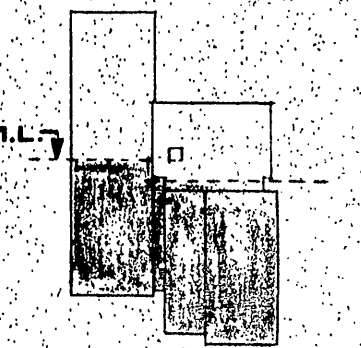


KEY PLAN

NO.	REVISION	DATE
1	AS-BUILT	5-1-83

DESIGNER	HDSR
ENGINEER	JMR
DRAWN BY	RLR
CHECKED BY	JMR
DATE:	JUNE 1, 1981

SOUTH  
UPPER  
LEVEL  
PLUMBING  
PLAN  
SCALE: 1/8" = 1'-0"

P-4

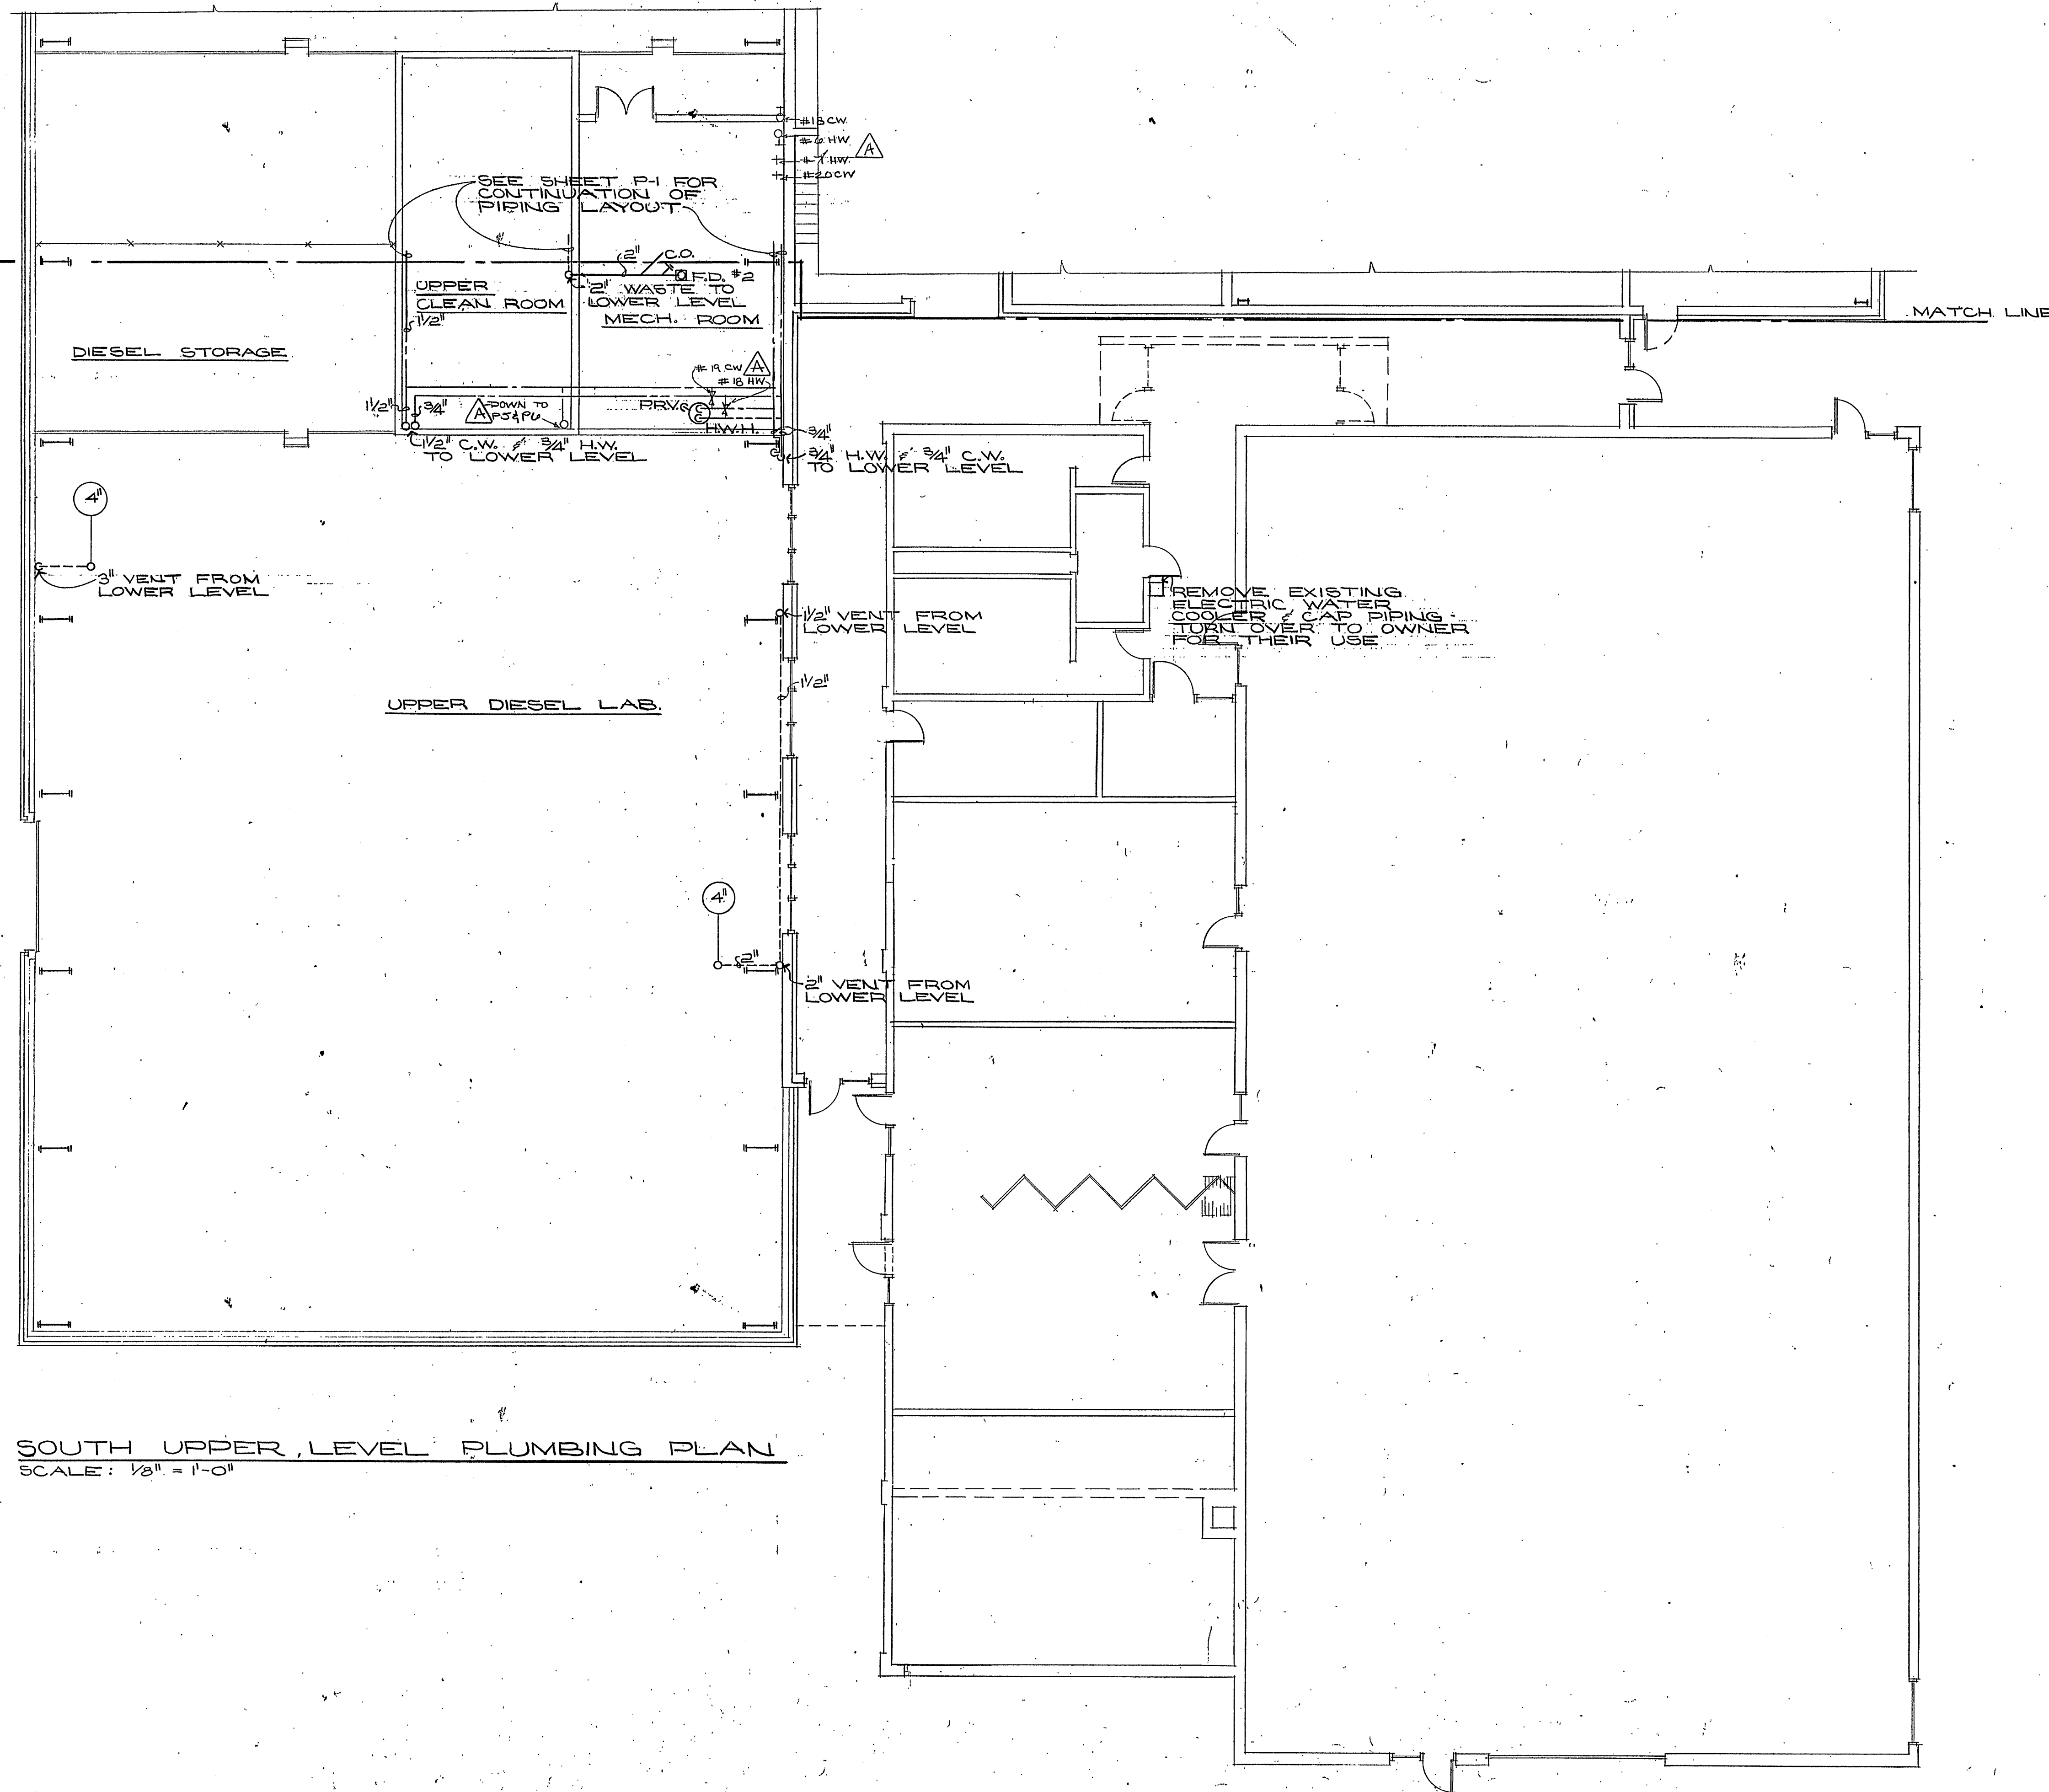

SOUTH UPPER LEVEL PLUMBING PLAN  
SCALE: 1/8" = 1'-0"